
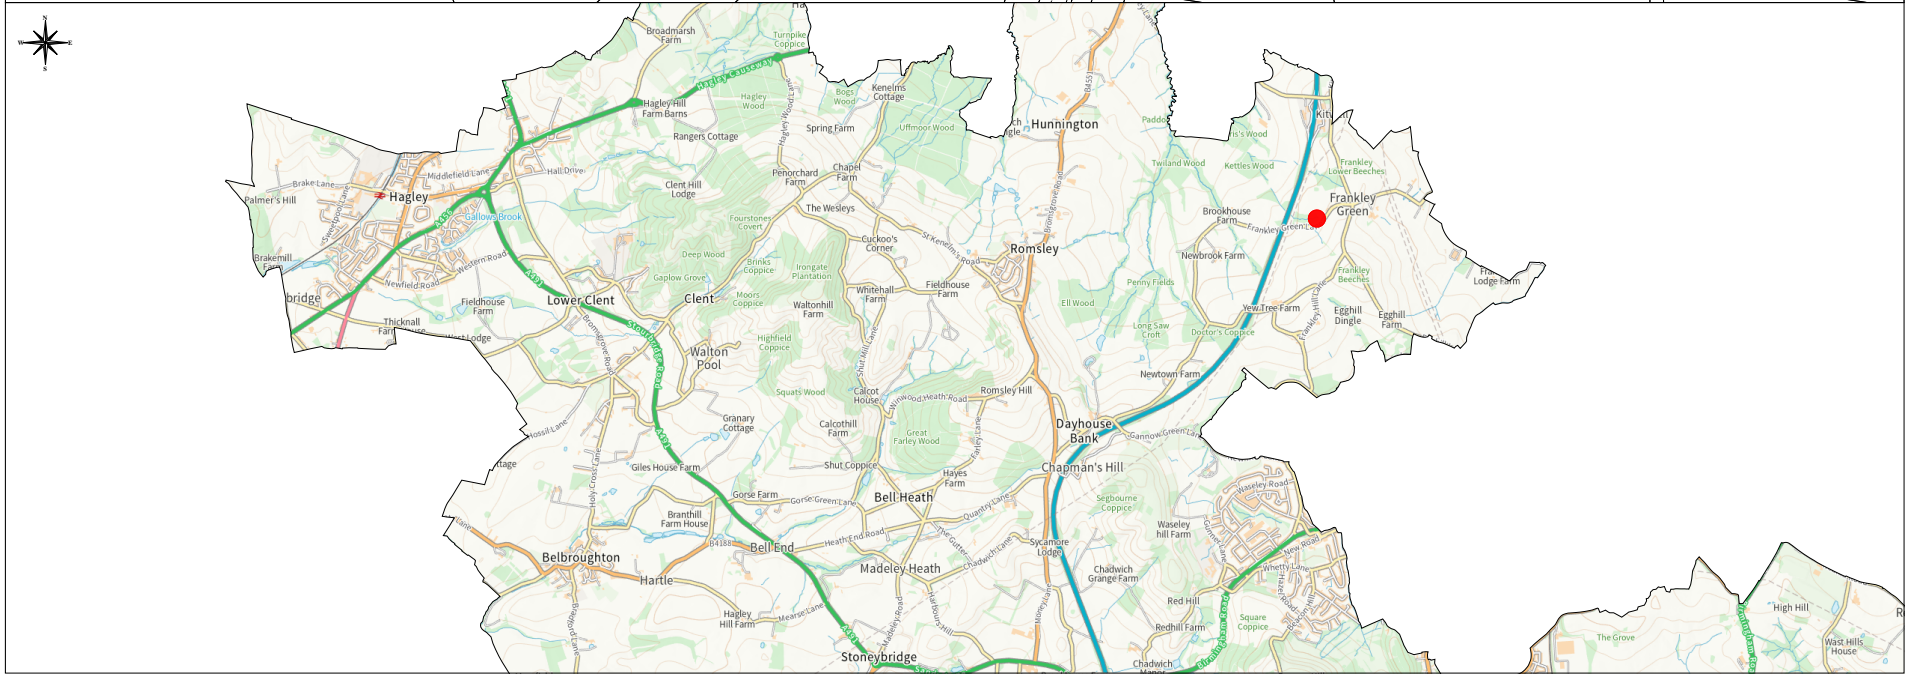


# Appendix 1

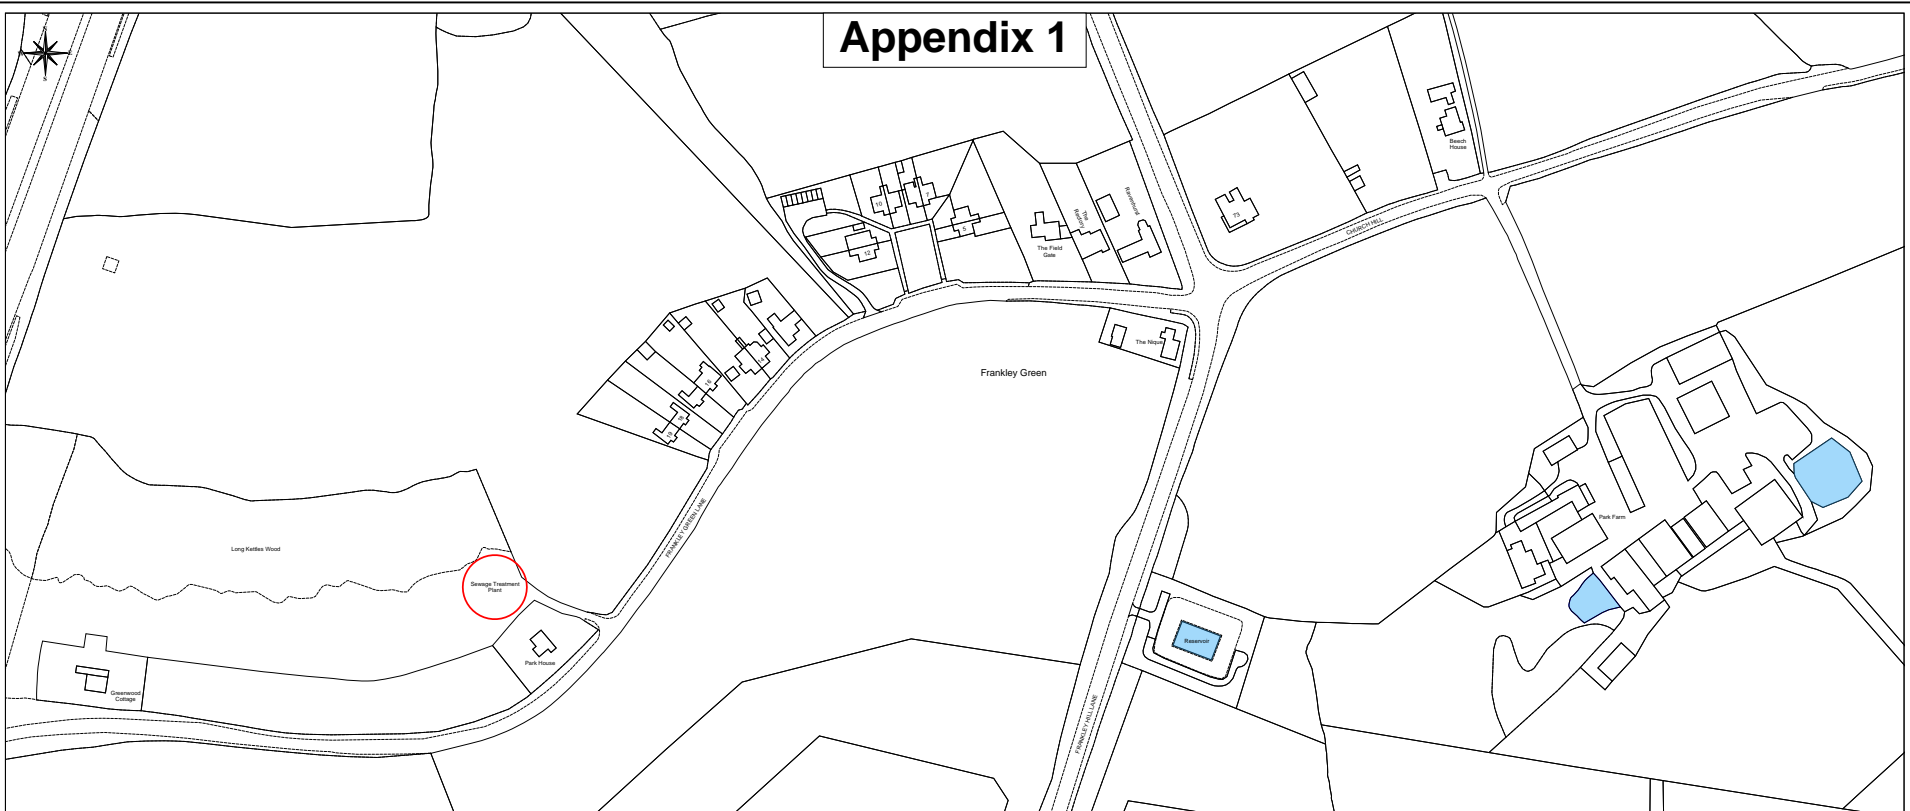

Date	Rev	Details

**Project:**  
**Frankley Green Sewage Treatment Plant**  
 Frankley Green Lane, Birmingham

**Drawing:**  
**Location and Site Plan**

Drawn:	PTL	Scale:	1/1250 and 1/25,000 @ A1
Surveyed:	OS	Date:	Mar 2022

**Drawing No:** P2240/1

**Engineering and Design Services**  
 Town Hall  
 Walter Strang Square  
 Redditch  
 Worcs B98 8AH

**REDDITCH BOROUGH COUNCIL**  
  
 making a difference  
[www.redditchbc.gov.uk](http://www.redditchbc.gov.uk)

**Bromsgrove District Council**  
  
[www.bromsgrove.gov.uk](http://www.bromsgrove.gov.uk)

© Crown Copyright and database rights 2022  
 Ordnance Survey 10004257